 





# Site Plan 1:500sc

## Legend

-  Surface Water - Low Level with high volume
-  Foul Water Drainage
-  Surface Water Drainage

# Playground

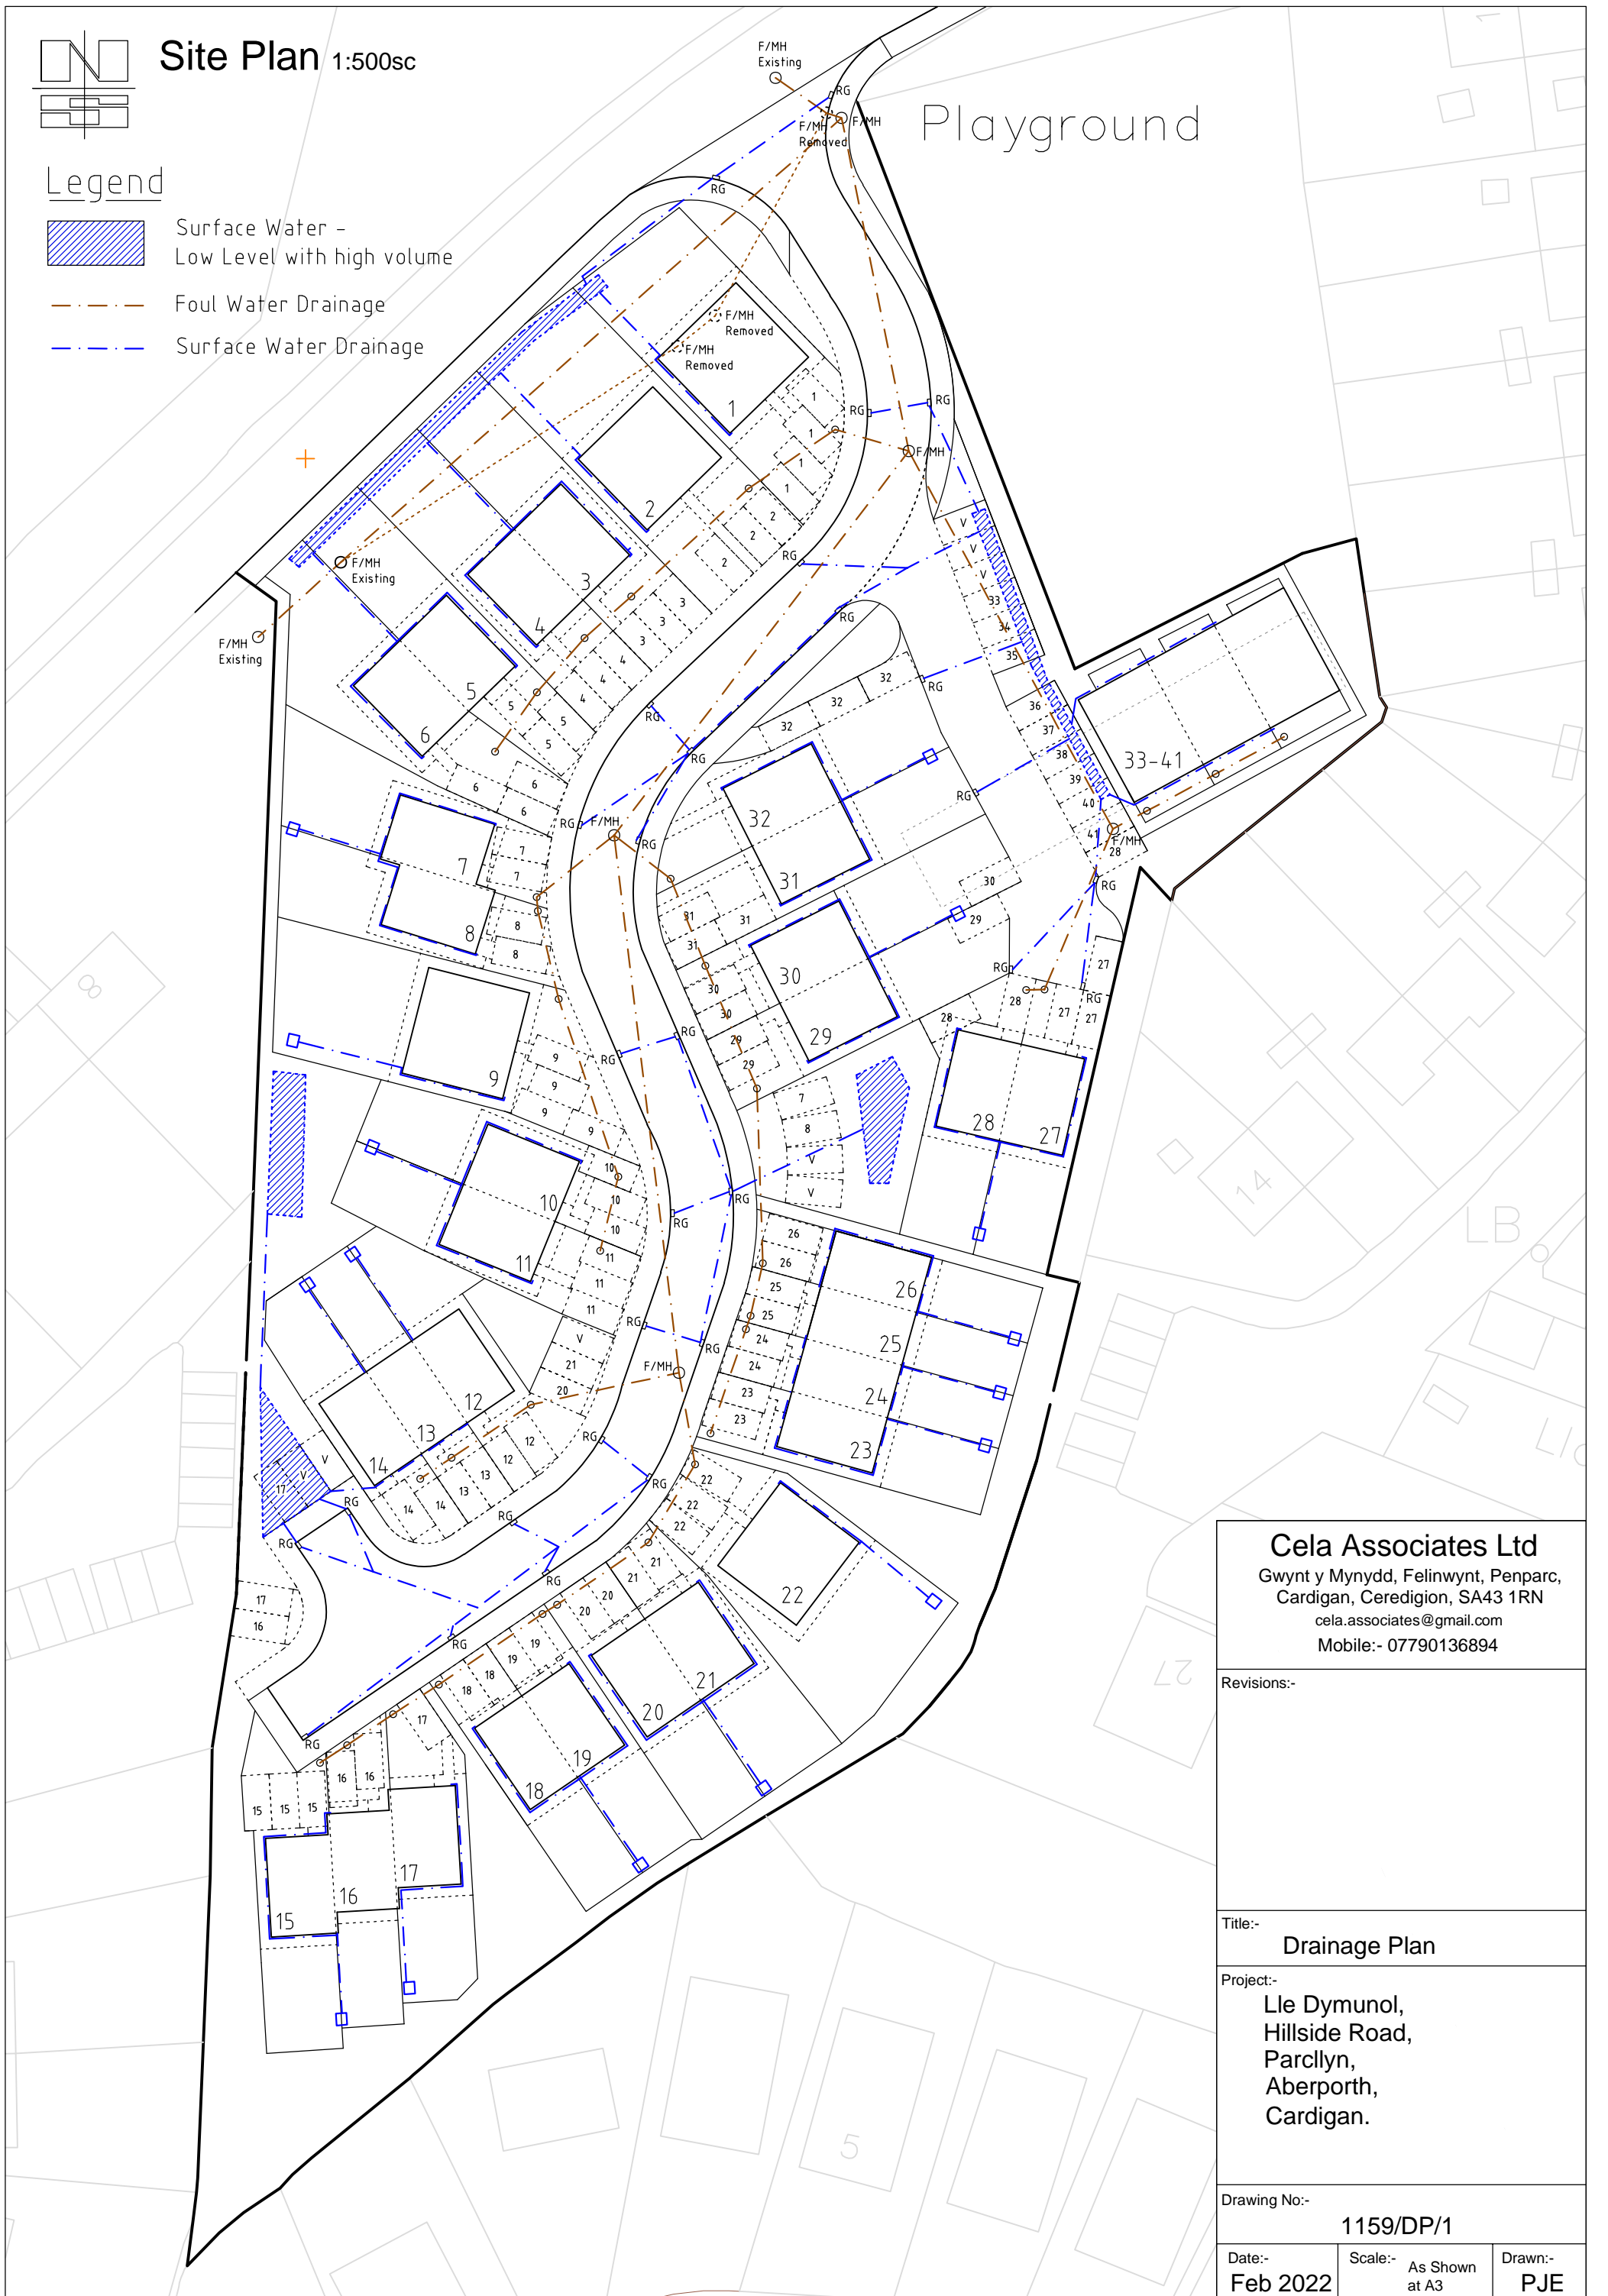

### Cela Associates Ltd

Gwynt y Mynydd, Felinwynt, Penparc,  
 Cardigan, Ceredigion, SA43 1RN  
 cela.associates@gmail.com  
 Mobile:- 07790136894

Revisions:-

Title:-

**Drainage Plan**

Project:-

**Lle Dymunol,  
 Hillside Road,  
 Parcllyn,  
 Aberporth,  
 Cardigan.**

Drawing No:-

**1159/DP/1**

Date:-

**Feb 2022**

Scale:-

As Shown  
at A3

Drawn:-

**PJE**